

Exhibit A Site Plan

Ojai Permanent Supportive Housing
Public Works Yard, Montgomery St, Ojai California

Drawn By: DJ
Checked By: Job No. 2407
Revisions:
No. Date By

NOT FOR CONSTRUCTION

14 March 2025

Design
Review

Architectural
Site Plan

A1.1

EXTERIOR BUILDING LIGHTING SCHEDULE

TAG	DESCRIPTION	FIXTURE MFR	FIXTURE MODEL	LAMP	LUMENS	WATTS	VOLTS	CRI	COLOR TEMP	FINISH	MOUNTING INFO
RX1	SOFFIT LIGHT	WAC	LOTOS 5"	LED	740	9 LINE	90	3000K	BLACK		18" FROM WALL
W1	ENTRY SCONCE	SAVOY	HANCOCK 23	LED BULB	450	5 LINE	90	2700K	BRONZE		90° TO TOP OF FIXTURE



W1: ENTRY SCONCE




RX1: SOFFIT LIGHTS

GENERAL NOTES
1. SEE CIVIL AND LANDSCAPE FOR ADDITIONAL SITE INFORMATION

ARCHITECTURAL SITE PLAN

1" = 20'

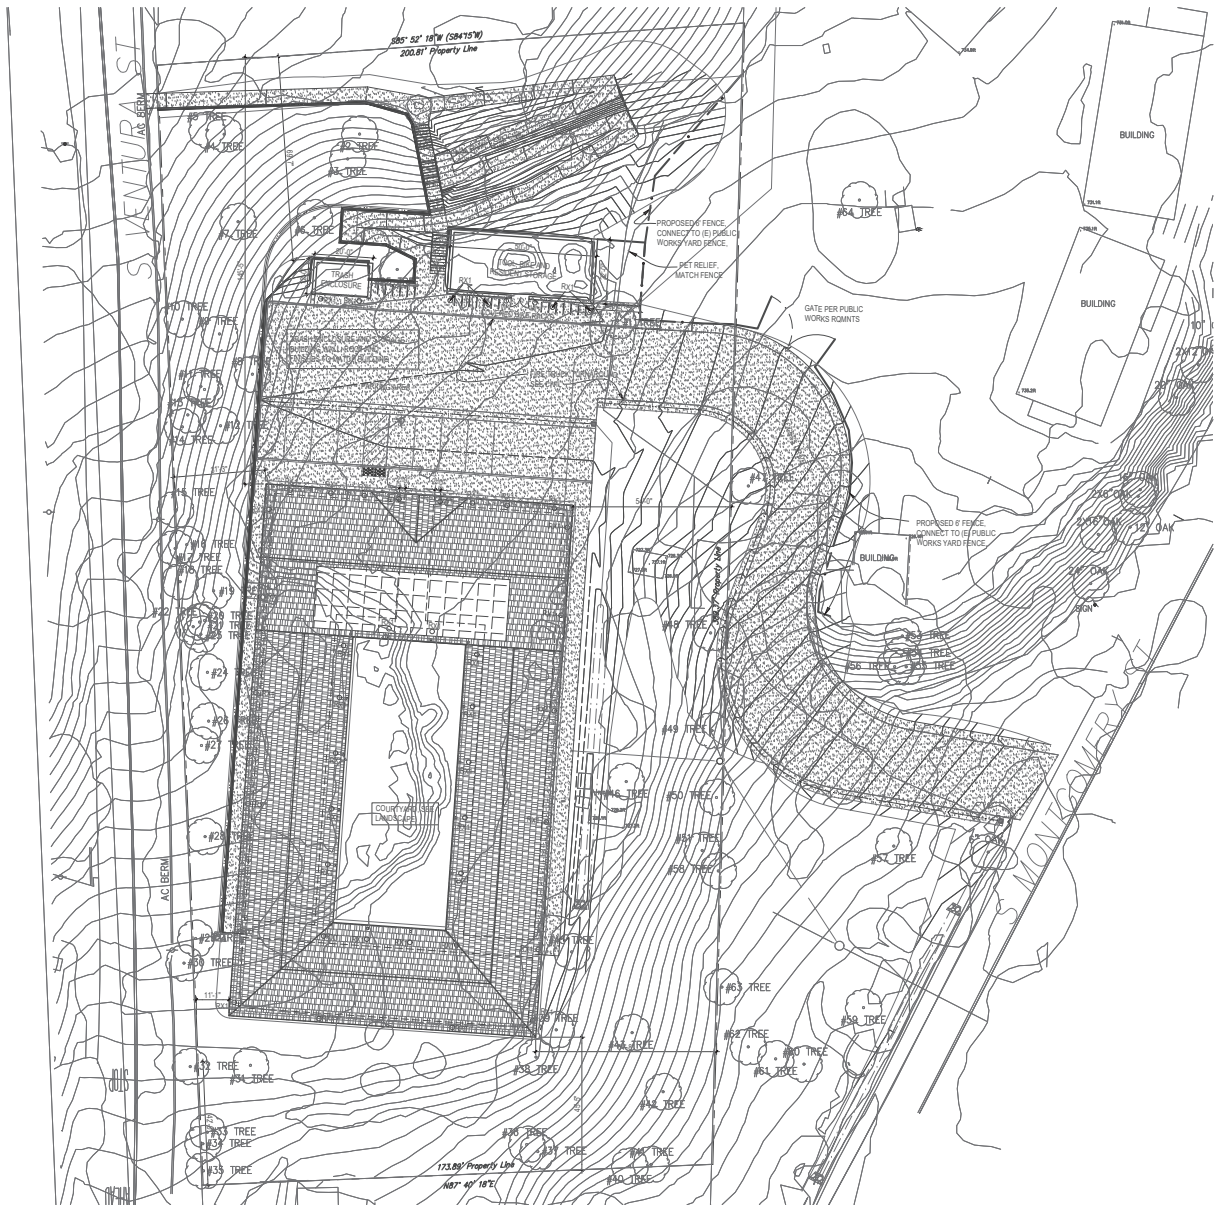

1
A1.1

1